



LEGEND	
	6" RECESSED TYPE DOWNLIGHT
	8" TUBULAR TYPE HOUSING, WITH LED BULB
	WALL SCONCE
	4" RECESSED TYPE DOWNLIGHT
	CHANDELIER
	INDUSTRIAL TYPE, T8 BULB
	DUCT FAN
	POST LAMP

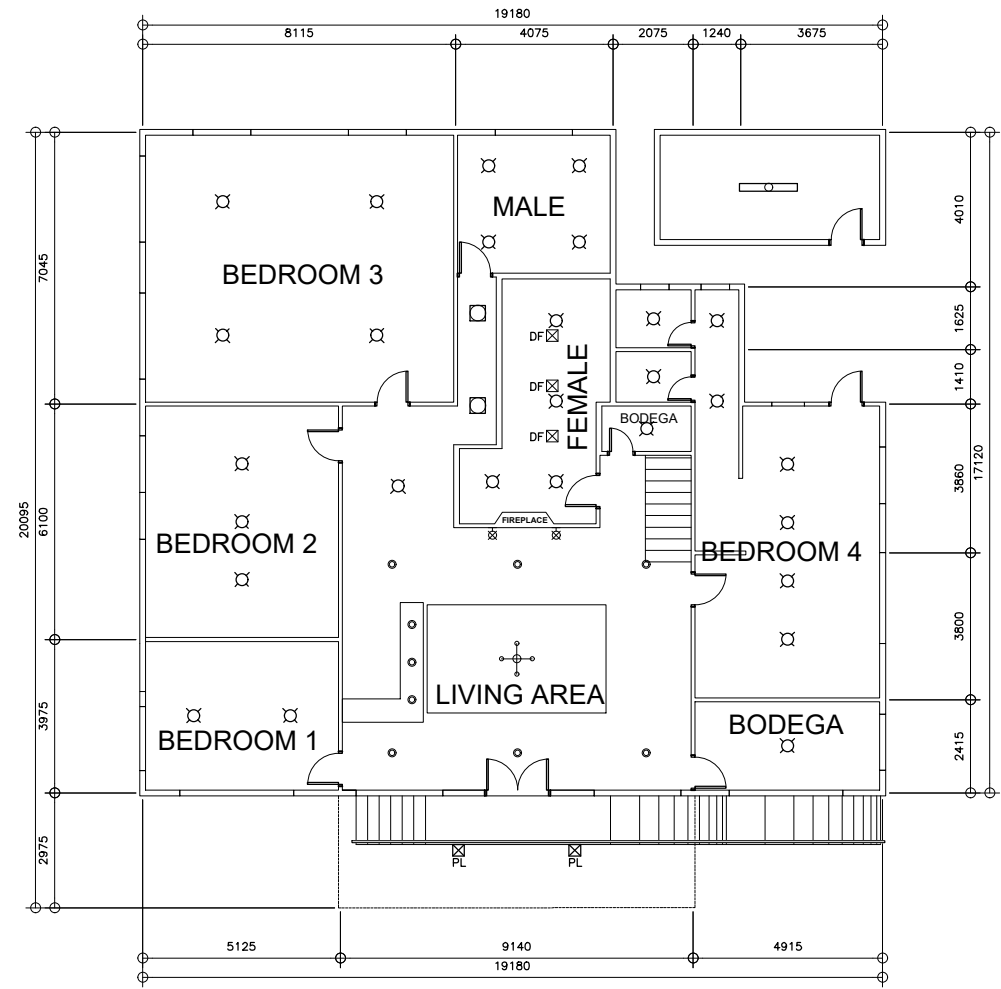



1 GROUND FLOOR LIGHTING LAYOUT
E-1 SCALE 1:200M

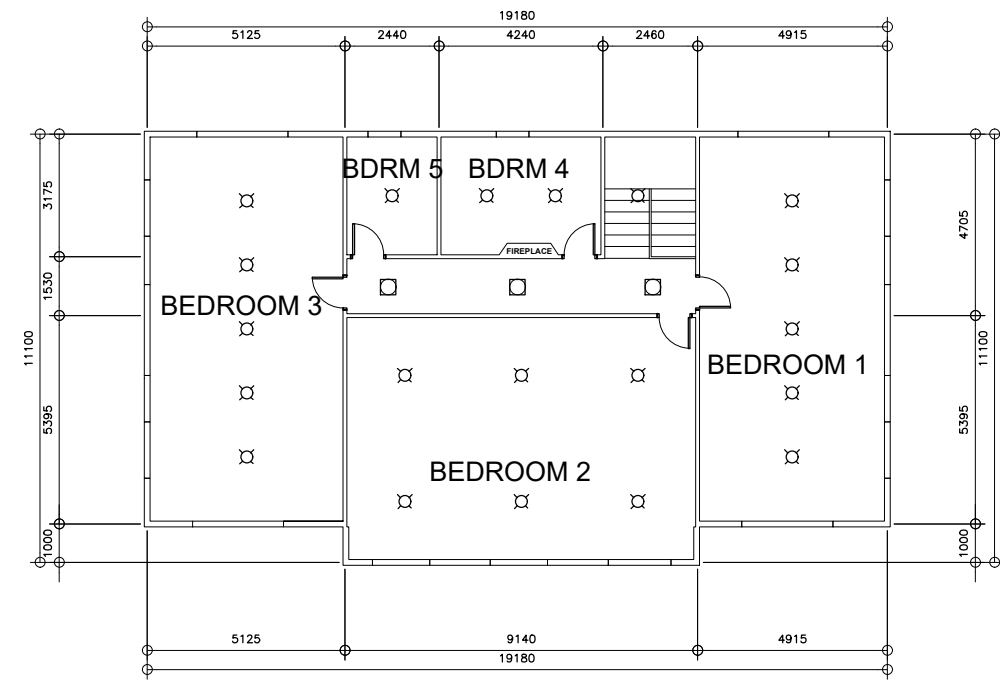

2 SECOND FLOOR LIGHTING LAYOUT
E-1 SCALE 1:200M

<p>REPUBLIC OF THE PHILIPPINES DEPARTMENT OF EDUCATION EDUCATION FACILITIES DIVISION MERALCO AVENUE, PASIG CITY</p>	<p>DRAWN BY :</p> <p></p> <p>JESTER SETH B. CALIXTO ELECTRICAL ENGINEER EFD-DepED</p>	<p>CHECKED BY :</p> <p></p> <p>SIEGMUND M. SANCHEZ PROFESSIONAL ELECTRICAL ENGINEER EFD-DepED</p>	<p>RECOMMENDING APPROVAL :</p> <p></p> <p>ANNABELLE R. PANGAN CHIEF, EFD DepED</p>	<p>RECOMMENDING APPROVAL :</p> <p></p> <p>DIOSDADO S. MEDINA CAMP SUPERINTENDENT BAGUIO TEACHERS CAMP, BAGUIO CITY</p>	<p>APPROVED BY :</p> <p></p> <p>NOLASCO A. MEMPIN UNDERSECRETARY FOR ADMINISTRATION DepED</p>	<p>PROJECT TITLE :</p> <p>REPAIR AND REHABILITATION OF ESCODA HALL</p> <p>LOCATION : BAGUIO TEACHERS CAMP, BAGUIO CITY</p>	<p>PROJECT CODE:</p>	<p>OWNER :</p> <p>DEPARTMENT OF EDUCATION DepED</p> <p>SHEET CONTENTS :</p> <p>GROUND FLOOR LIGHTING LAYOUT SECOND FLOOR LIGHTING LAYOUT</p>	<p>SHEET NO:</p> <p>E-1 4</p>
---------------------------------------------------------------------------------------------------------------------------------	-----------------------------------------------------------------------------------------------	-----------------------------------------------------------------------------------------------------------	--------------------------------------------------------------------------------------------	--------------------------------------------------------------------------------------------------------------------------------	-------------------------------------------------------------------------------------------------------	--------------------------------------------------------------------------------------------------------------------------------	----------------------	------------------------------------------------------------------------------------------------------------------------------------------------------	-----------------------------------


LEGEND	
	DUPLEX CONVENIENCE OUTLET
	WEATHERPROOF DUPLEX CONVENIENCE OUTLET
	PANELBOARD

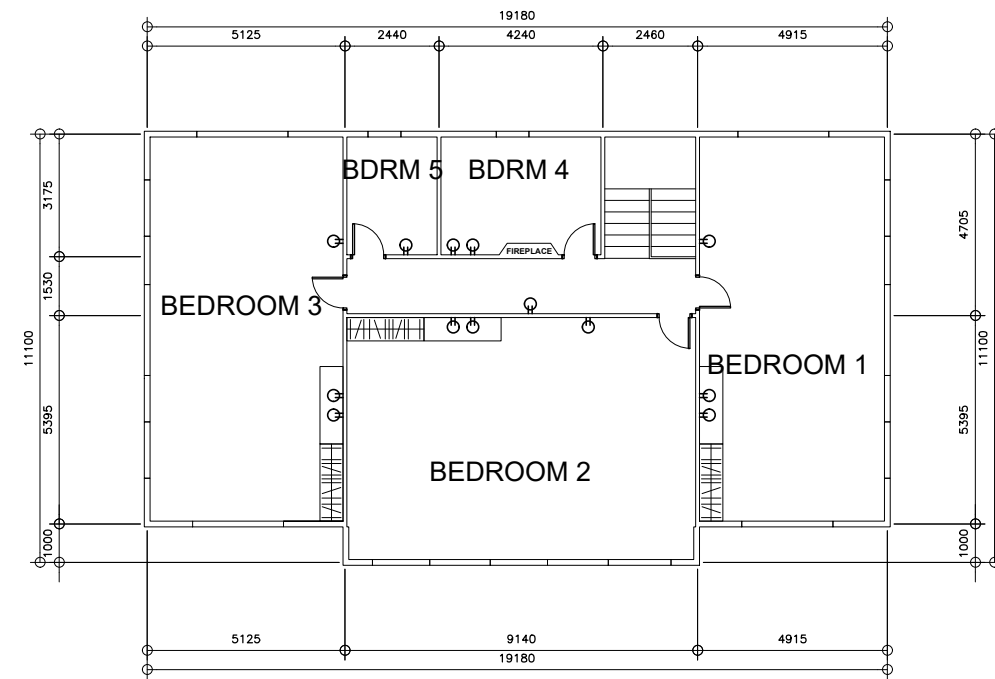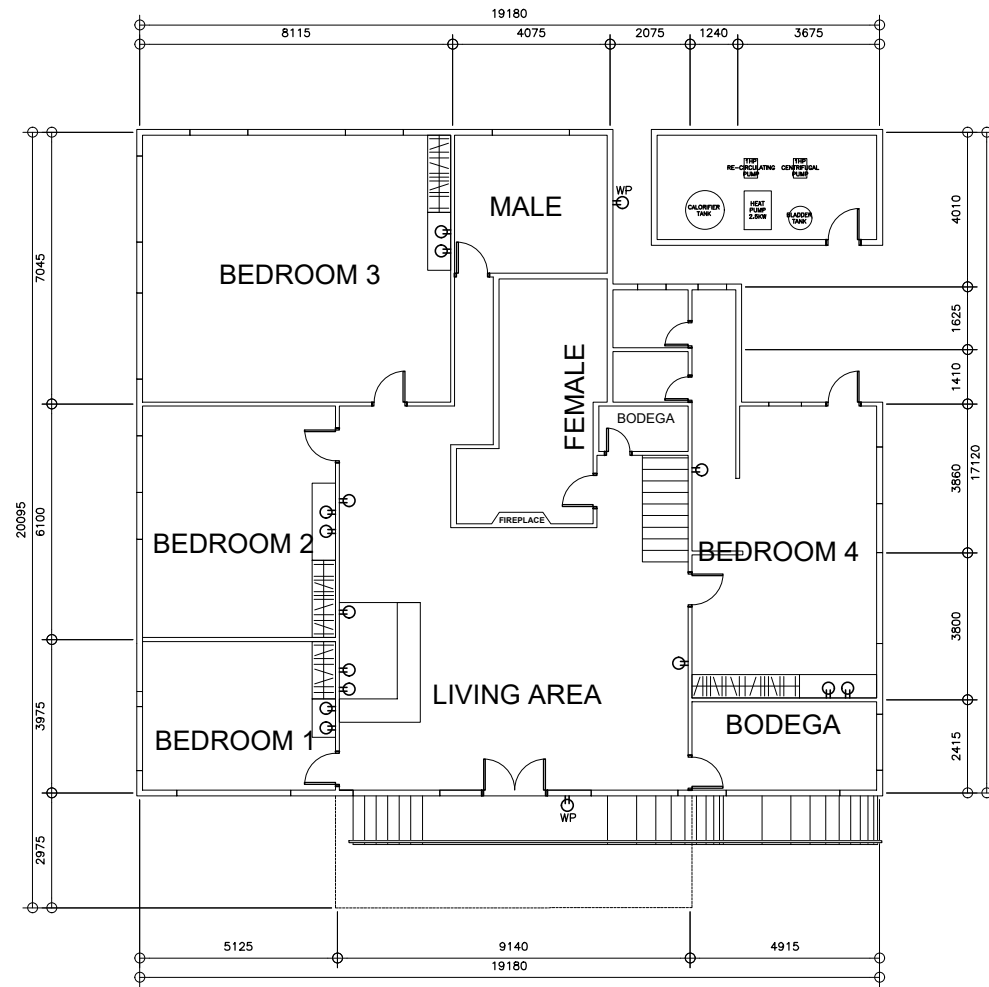


1 GROUND FLOOR POWER LAYOUT
E-2 SCALE 1:200M

2 SECOND FLOOR POWER LAYOUT
E-2 SCALE 1:200M

<p>REPUBLIC OF THE PHILIPPINES DEPARTMENT OF EDUCATION EDUCATION FACILITIES DIVISION MERALCO AVENUE, PASIG CITY</p>	DRAWN BY : JESTER SETH B. CALIXTO ELECTRICAL ENGINEER EFD-DepED	CHECKED BY : SIEGMUND M. SANCHEZ PROFESSIONAL ELECTRICAL ENGINEER EFD-DepED	RECOMMENDING APPROVAL : ANNABELLE R. PANGAN CHIEF, EFD DepED	RECOMMENDING APPROVAL : DIOSDADO S. MEDINA CAMP SUPERINTENDENT BAGUIO TEACHERS CAMP, BAGUIO CITY	APPROVED BY : NOLASCO A. MEMPIN UNDERSECRETARY FOR ADMINISTRATION DepED	PROJECT TITLE : REPAIR AND REHABILITATION OF ESCODA HALL	PROJECT CODE:	OWNER : DEPARTMENT OF EDUCATION DepED	SHEET NO.: E-2 4
	LOCATION : BAGUIO TEACHERS CAMP, BAGUIO CITY						SHEET CONTENTS : GROUND FLOOR POWER LAYOUT SECOND FLOOR POWER LAYOUT		

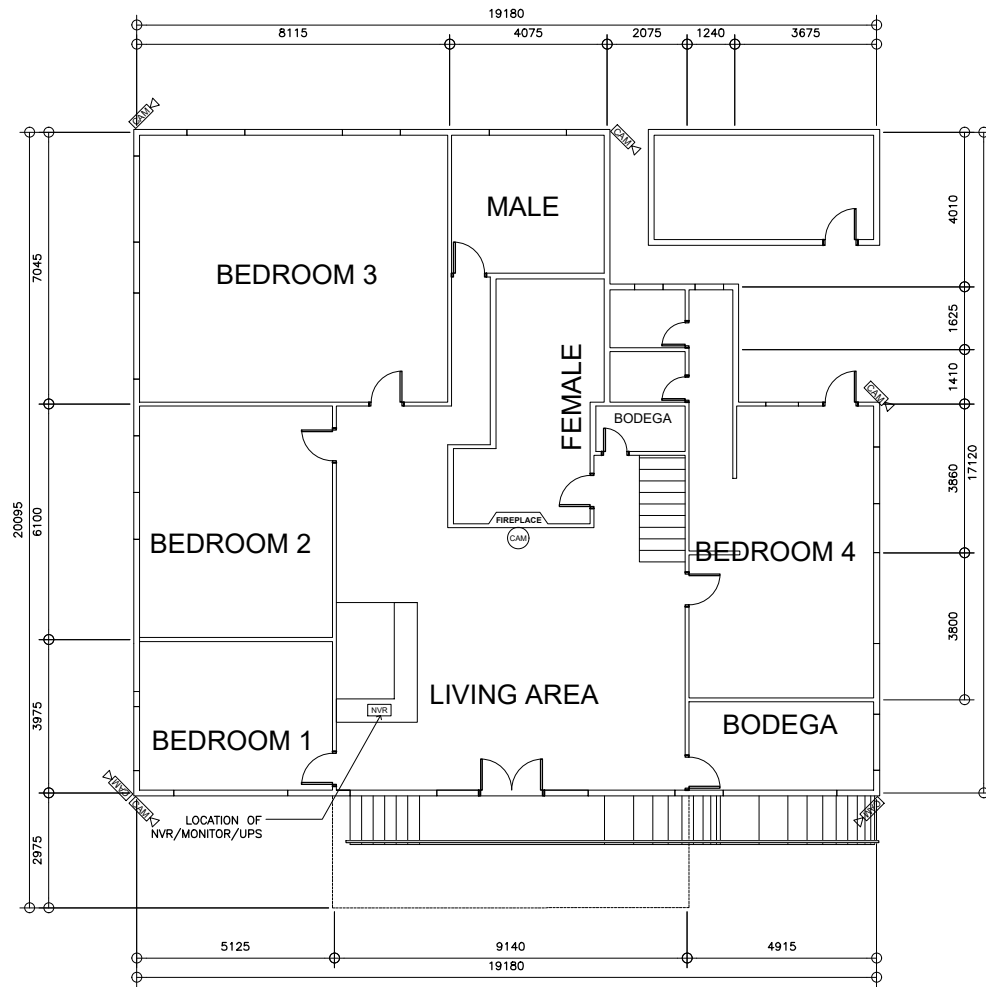


LEGEND	
	BULLET/DOME TYPE CAMERA
	NETWORK VIDEO RECORDER

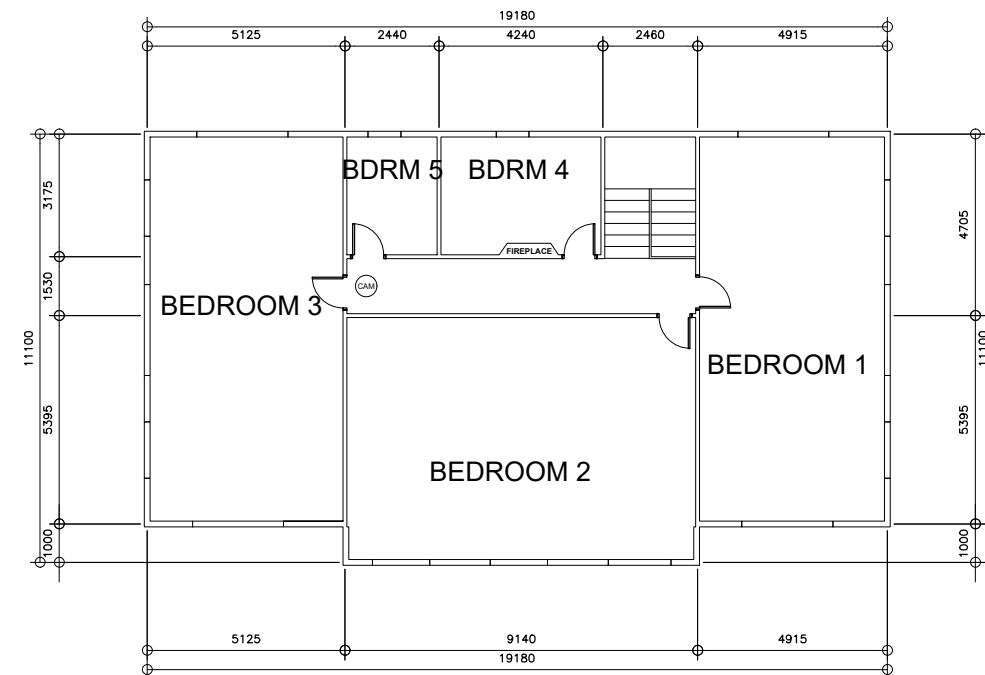


1 GROUND FLOOR CCTV LAYOUT
E-3 SCALE 1:200M

2 SECOND FLOOR CCTV LAYOUT
E-3 SCALE 1:200M

<p>REPUBLIC OF THE PHILIPPINES DEPARTMENT OF EDUCATION EDUCATION FACILITIES DIVISION MERALCO AVENUE, PASIG CITY</p>	<p>DRAWN BY :</p> <p></p> <p>JESTER SETH B. CALIXTO ELECTRICAL ENGINEER EFD-DepED</p>	<p>CHECKED BY :</p> <p></p> <p>SIEGMUND M. SANCHEZ PROFESSIONAL ELECTRICAL ENGINEER EFD-DepED</p>	<p>RECOMMENDING APPROVAL :</p> <p></p> <p>ANNABELLE R. PANGAN CHIEF, EFD DepED</p>	<p>RECOMMENDING APPROVAL :</p> <p></p> <p>DIOSDADO S. MEDINA CAMP SUPERINTENDENT BAGUIO TEACHERS CAMP, BAGUIO CITY</p>	<p>APPROVED BY :</p> <p></p> <p>NOLASCO A. MEMPIN UNDERSECRETARY FOR ADMINISTRATION DepED</p>	<p>PROJECT TITLE :</p> <p>REPAIR AND REHABILITATION OF ESCODA HALL</p> <p>LOCATION : BAGUIO TEACHERS CAMP, BAGUIO CITY</p>	<p>PROJECT CODE:</p>	<p>OWNER :</p> <p>DEPARTMENT OF EDUCATION DepED</p> <p>SHEET CONTENTS : GROUND FLOOR CCTV LAYOUT SECOND FLOOR CCTV LAYOUT</p>	<p>SHEET NO:</p> <p>E-3 4</p>
---------------------------------------------------------------------------------------------------------------------------------	------------------------------------------------------------------------------------------------------	------------------------------------------------------------------------------------------------------------------	---------------------------------------------------------------------------------------------------	---------------------------------------------------------------------------------------------------------------------------------------	--------------------------------------------------------------------------------------------------------------	-----------------------------------------------------------------------------------------------------------------------------------	----------------------	--------------------------------------------------------------------------------------------------------------------------------------------------	-------------------------------------------------

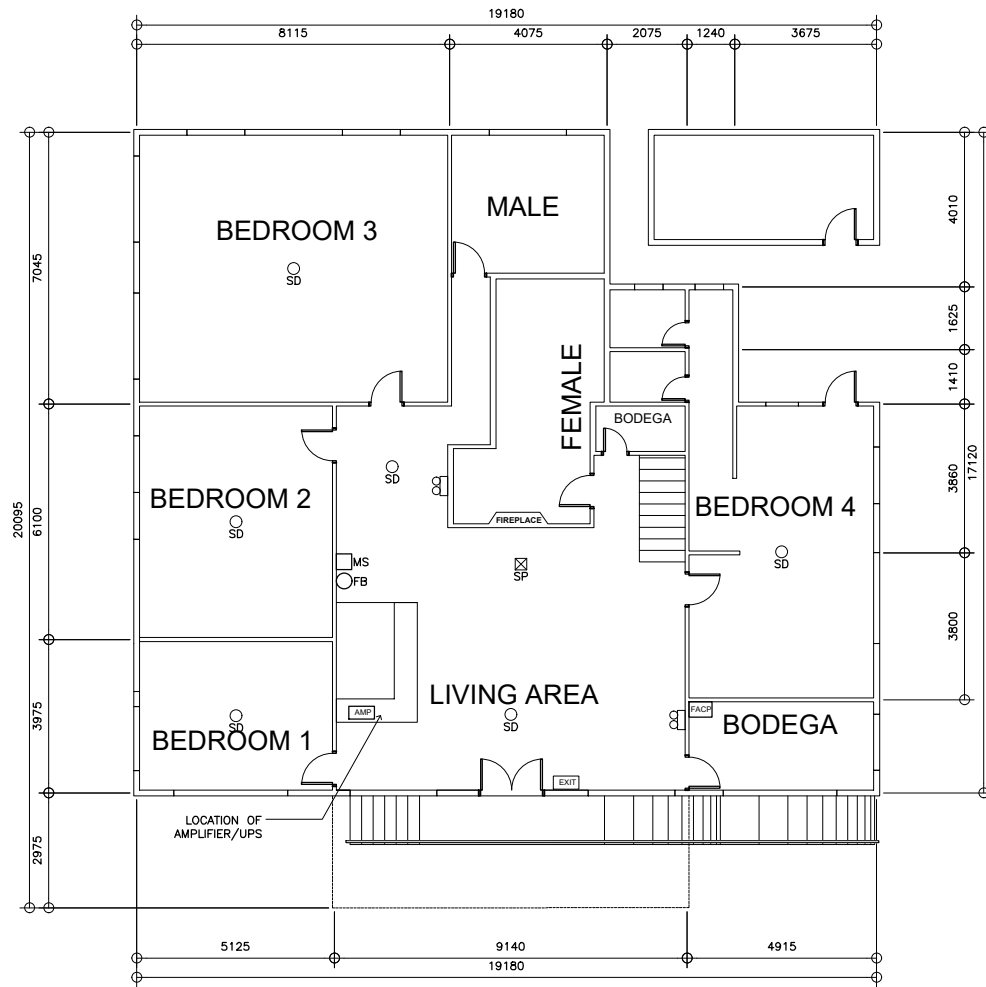

LEGEND	
○SD	SMOKE DETECTOR
⊗SP	SPEAKER
⊞	2-BEAM EMERGENCY LIGHT
□MS	MANUAL STATION
○FB	FIRE ALARM BELL
AMP	AMPLIFIER
FACP	FIRE ALARM CONTROL PANEL
EXIT	EXIT SIGNAGE

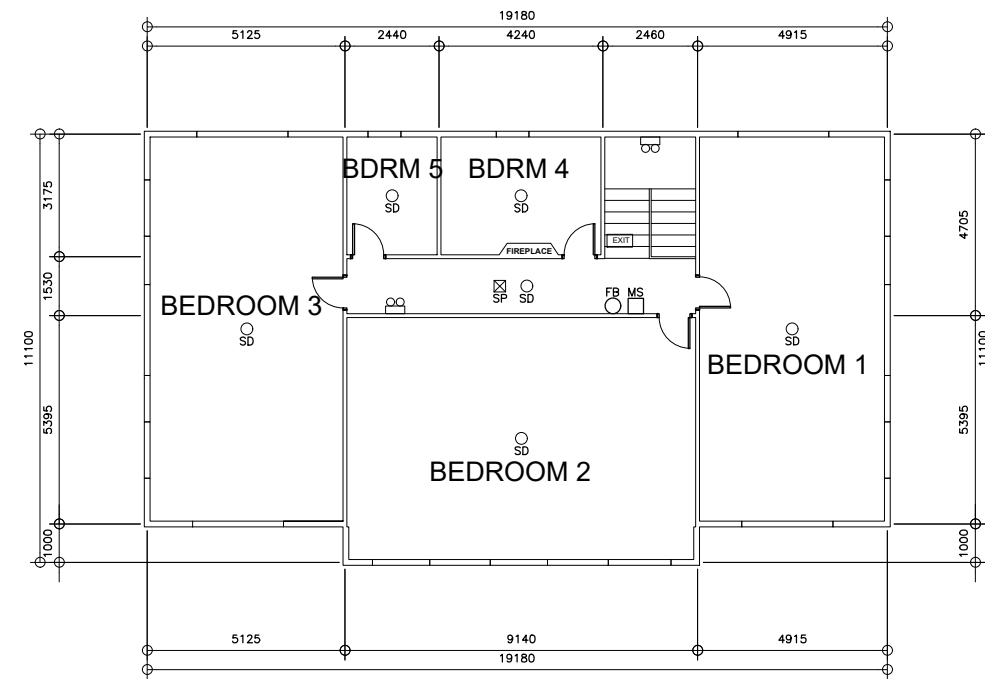

1
E-4
GROUND FLOOR AUDIO/FIRE LAYOUT
SCALE 1:200M

2
E-4
SECOND FLOOR AUDIO/FIRE LAYOUT
SCALE 1:200M

<p>REPUBLIC OF THE PHILIPPINES DEPARTMENT OF EDUCATION EDUCATION FACILITIES DIVISION MERALCO AVENUE, PASIG CITY</p>	<p>DRAWN BY :</p> <p><i>Jester S. Calixto</i> JESTER SETH B. CALIXTO ELECTRICAL ENGINEER EFD-DepED</p>	<p>CHECKED BY :</p> <p><i>Siegmund M. Sanchez</i> SIEGMUND M. SANCHEZ PROFESSIONAL ELECTRICAL ENGINEER EFD-DepED</p>	<p>RECOMMENDING APPROVAL :</p> <p><i>Annabelle R. Pangan</i> ANNABELLE R. PANGAN CHIEF, EFD DepED</p>	<p>RECOMMENDING APPROVAL :</p> <p><i>Diosdado S. Medina</i> DIOSDADO S. MEDINA CAMP SUPERINTENDENT BAGUIO TEACHERS CAMP, BAGUIO CITY</p>	<p>APPROVED BY :</p> <p><i>Nolasco A. Mempin</i> NOLASCO A. MEMPIN UNDERSECRETARY FOR ADMINISTRATION DepED</p>	<p>PROJECT TITLE :</p> <p>REPAIR AND REHABILITATION OF ESCODA HALL</p>	<p>PROJECT CODE :</p>	<p>OWNER :</p> <p>DEPARTMENT OF EDUCATION DepED</p>	<p>SHEET NO.:</p> <p>E-4 4</p>
	<p>LOCATION : BAGUIO TEACHERS CAMP, BAGUIO CITY</p>						<p>SHEET CONTENTS :</p> <p>GROUND FLOOR PLAN AUDIO/FIRE LAYOUT SECOND FLOOR PLAN AUDIO/FIRE LAYOUT</p>		